



1 POINT OF SUPPLY CONNECTION
NOT TO SCALE



2 CONCEPT NEW MAIN SWITCHBOARD
NOT TO SCALE

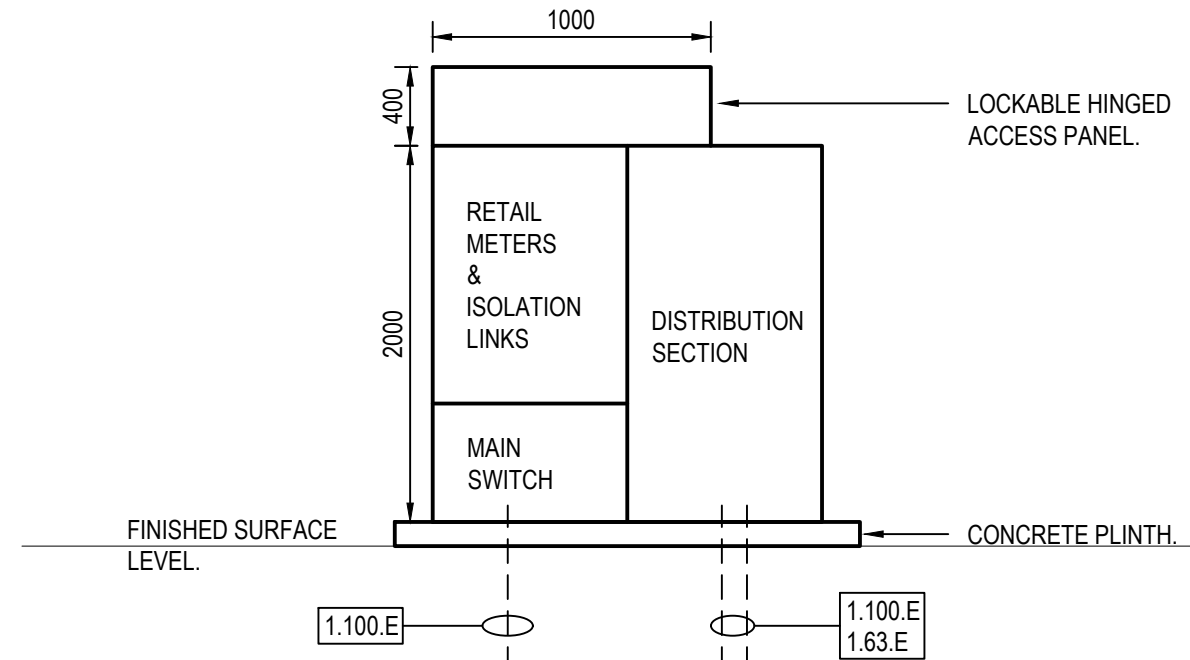

SITE PLAN
APPROX SCALE 1:200

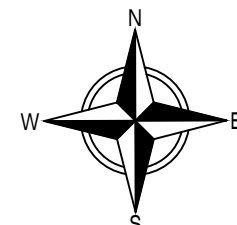

TENDER ISSUE

GENERAL NOTES:
© Copyright, Anderson Consulting Engineers Pty. Ltd.
Do not scale from this drawing. Take measurements on site prior to commencing work.

08/05/24	B	CONDUIT SIZING ALTERED	G.A.
23/04/24	A	TENDER ISSUE	G.A.
Date	Rev	Details	App

Client:
BANANA SHIRE COUNCIL

ANDERSON
CONSULTING ENGINEERS
43 Derison Street, Rockhampton, Q. 4700
P.O. Box 27, Rockhampton, Q. 4700
Phone: (07) 4927 2077
Email: admin@andersonce.com.au
ACN: 112 066 529 ABN: 98 112 066 529

Project:
RAINBOW STREET, BILOELA
SPORTS PRECINCT

Title:
ELECTRICAL SERVICES
SITE PLAN, ELEVATIONS.

Drawing No: 23165R-E001		Rev: B
Drawn: VMC	Designed: G.A.	
Scale @ A1: APPROX. 1:200	Approved: G.A.	
Date: APRIL 24	No: 1	Of: 2