


FILE: K:\PROJECTS\23-048\DWGS\MECH\23-048_M02.dwg PLOTTED: lcomp 19 May, 2023 - 12:28pm

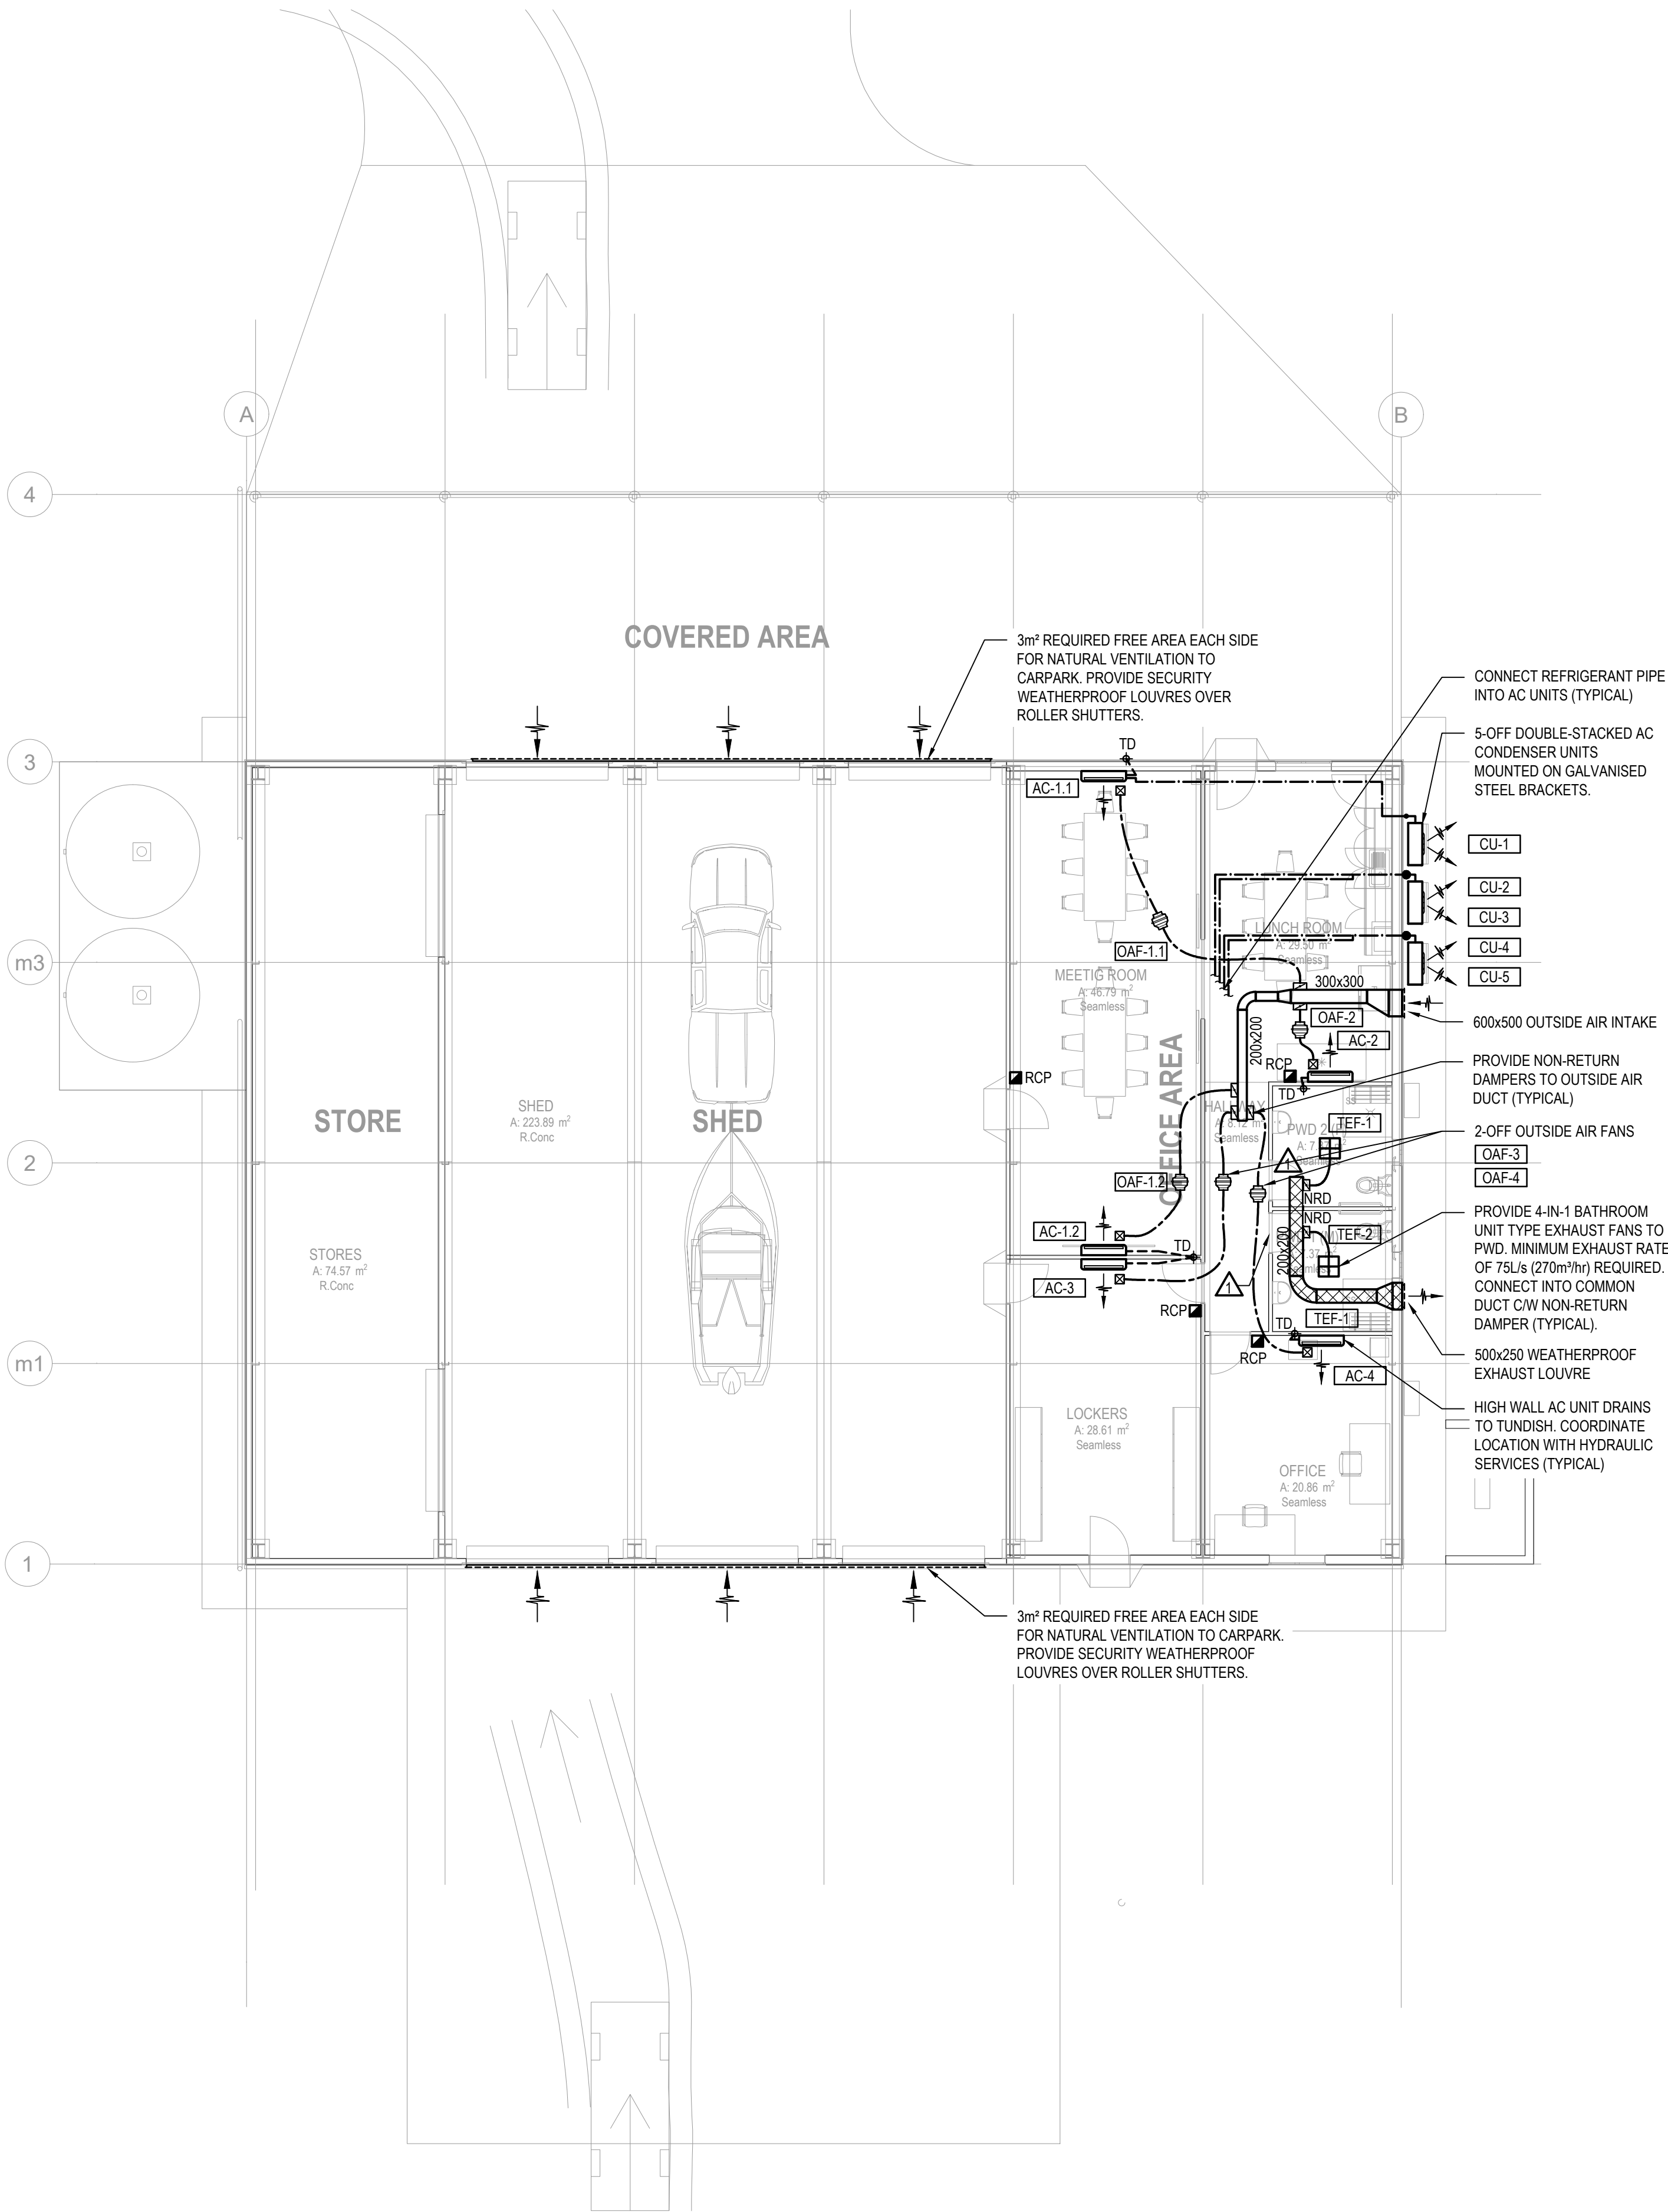

DO NOT SCALE ANY PART OF THIS DRAWING

ALL DIMENSIONS ARE TO BE TAKEN FROM THE ARCHITECTS DRAWINGS & ON SITE

rev	date	drawn	reason for issue
1	19.05.23	LP	FINAL REVIEW

FINAL REVIEW

consulting engineer

CUSHWAY BLACKFORD
CONSULTING ENGINEERS

Cushway Blackford & Associates Pty Ltd
ABN 23 010 522 988

P 07 3896 1100
E reception@cushway.com.au

5 Trafalgar Street, Woolloongabba QLD 4102
PO Box 1517, Coorparoo DC QLD 4151

architect

Mailing Address
262 Grubb St
Koongah QLD 4701
andrew@ambuildingdesign.com.au
0423 375 400

QBCC No 1068756
ABN 22 143 527 198
all projects
residential,commercial,industrial

amb
BUILDING DESIGN

project

**PROPOSED TAROOM
SES FACILITY
45 HUTTON ST
TAROOM QLD**

drawing title

**AIR CONDITIONING
& MECHANICAL
VENTILATION LAYOUT**

MECHANICAL SERVICES

scale
1:100 @A1

project number
23-048

drawing number
M02

designed
LP

drawn
LP

revision
1